

**LEGEND:**

- FLOURESCENT, 2' X 4' LAY IN 3 TUBE, 120V
- EXIT/EMERGENCY LIGHT WITH BATTERY BACK-UP
- EXTERIOR MAIN DISCONNECT, CLASS 1 DIV 2
- EXTERIOR LIGHT, 60W INCANDESCANT CLASS 1 DIV 2
- DUPLEX RECEPTACLE, 120V, 20 AMP
- DUPLEX RECEPTACLE GFCI 120V, 20 AMP
- WATER HEATER RECEPTACLE, 120V, 20 AMP TWIST'LOCK
- SWITCH SINGLE POLE, 120V 20 AMP
- SAFE HAVEN SWITCH SINGLE POLE, 120V 20 AMP, RED COVER PLATE
- VOICE/DATA QUADJACK 2 VOICE/2 DATA RJ45-568 A/B
- COMMUNICATIONS JUNCTION BOXES
- LOAD CENTER
- SMOKE DETECTOR, 120V
- THERMOSTAT
- WALL MOUNTED FIRE EXTINGUISHER
- EXHAUST FAN
- WIRE MANAGEMENT BUSHING


**HUNTER**  
BUILDINGS & MANUFACTURING, LP

U.S. STANDARD  
LAYOUT #1  
BUILDING FLOOR PLAN

BY	DATE	SCALE:	3/8"=1'-0"
DRAWN: AD	1/5/07	JOB. No.	STANDARD
CHECKED: HGW	1/5/07		
ENGINEER:			
APPROVED:			

NO.	DATE	DESCRIPTION	BY	CHKD.	NO.	DATE	DESCRIPTION	BY	CHKD.
-	-	-	-	-	-	-	-	-	-
-	-	-	-	-	0	1/5/07	ISSUED FOR CONSTRUCTION	AD	HGW

LAYOUT #1 A-01 REV 0

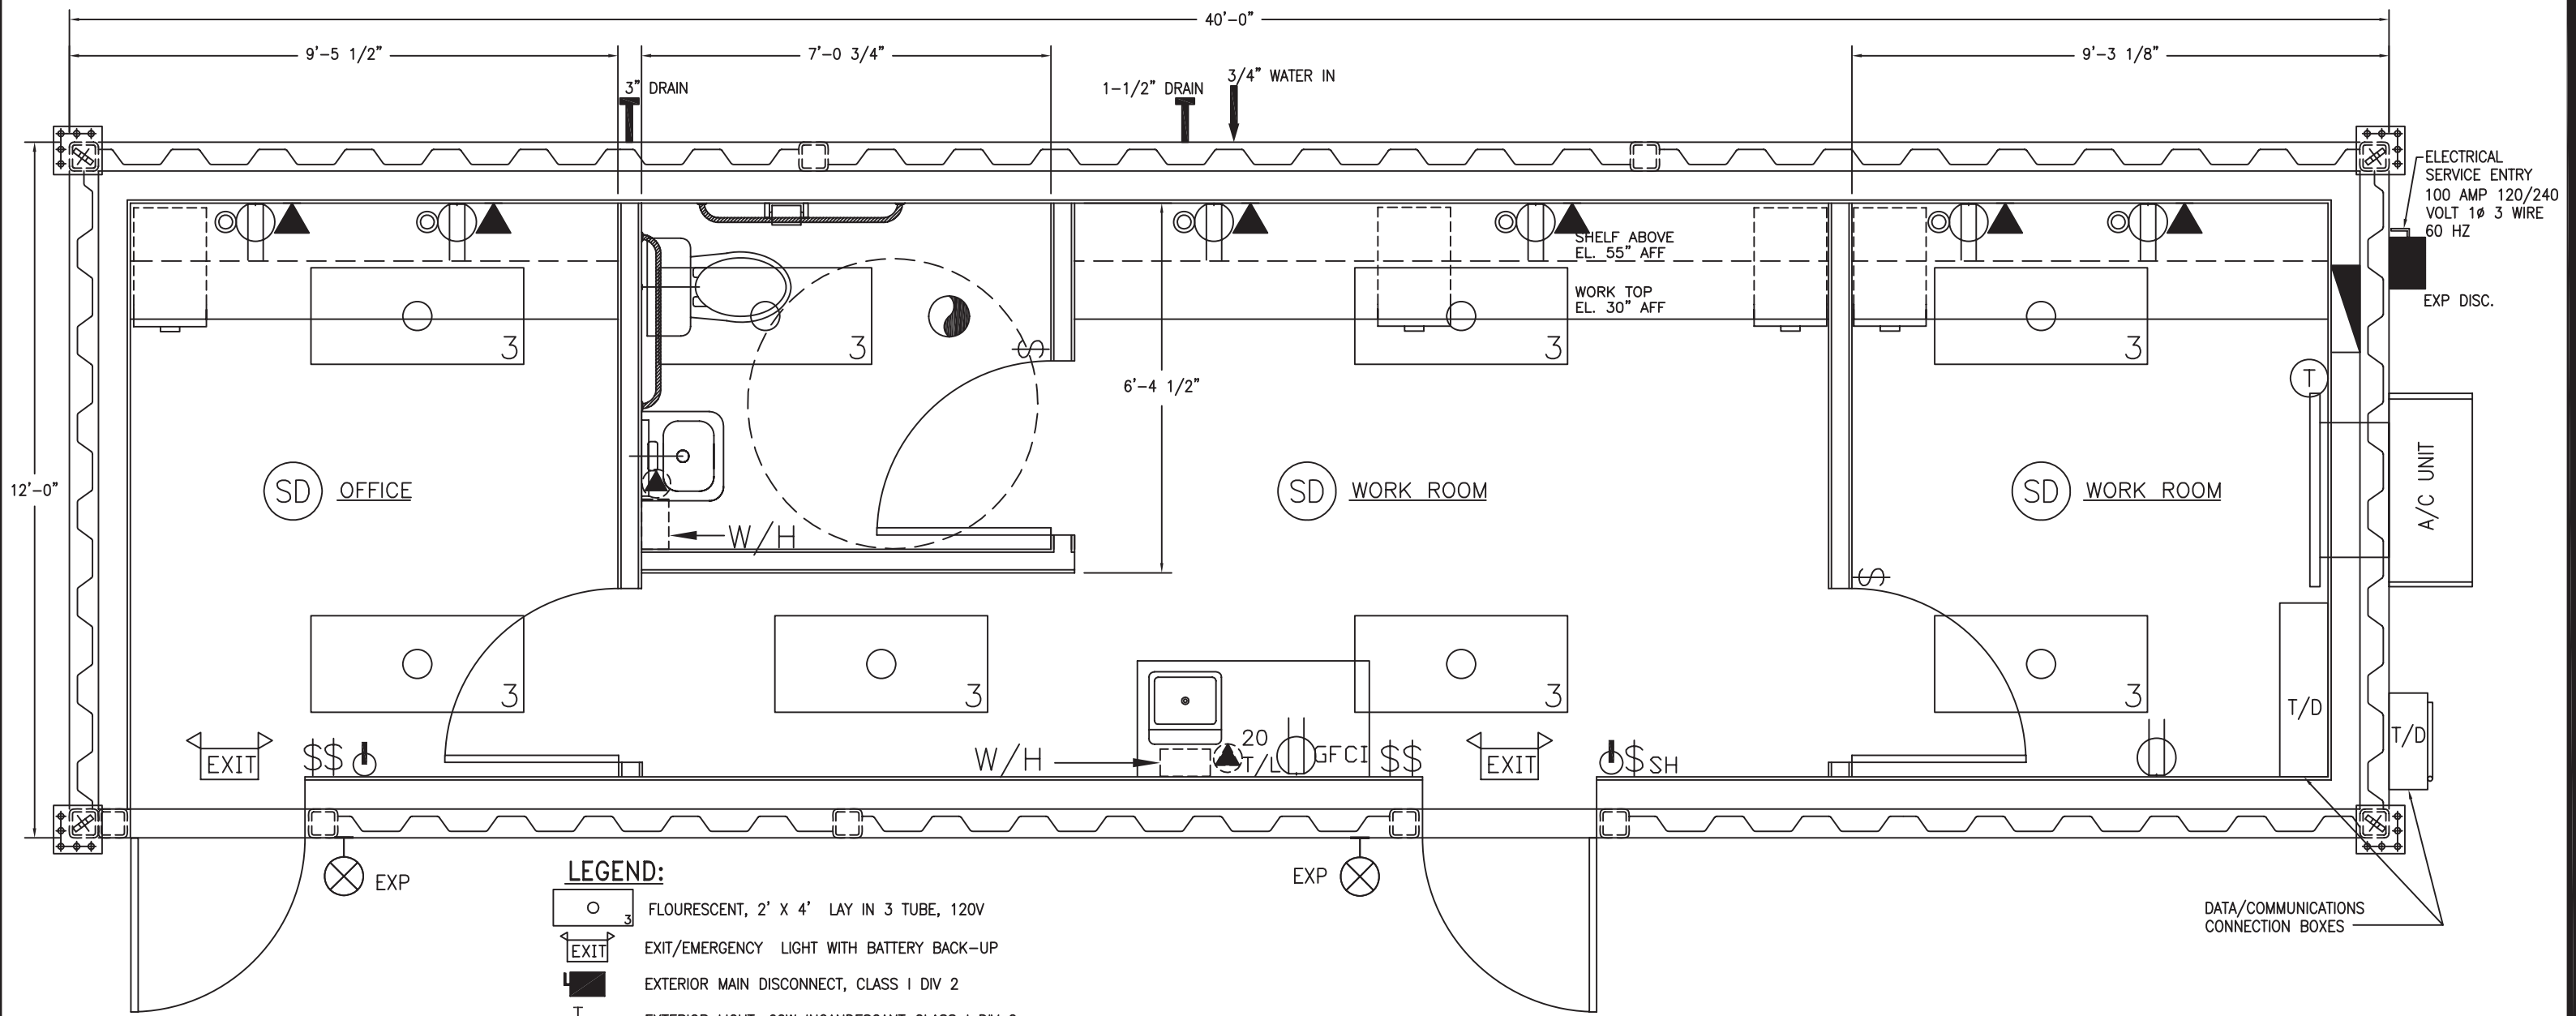

**LEGEND:**

- FLOURESCENT, 2' X 4' LAY IN 3 TUBE, 120V
- EXIT/EMERGENCY LIGHT WITH BATTERY BACK-UP
- EXTERIOR MAIN DISCONNECT, CLASS I DIV 2
- EXTERIOR LIGHT, 60W INCANDESCANT CLASS I DIV 2
- DUPLEX RECEPTACLE, 120V, 20 AMP
- DUPLEX RECEPTACLE GFCI 120V, 20 AMP
- WATER HEATER RECEPTACLE, 120V, 20 AMP TWIST'LOCK
- SWITCH SINGLE POLE, 120V 20 AMP
- SAFE HAVEN SWITCH SINGLE POLE, 120V 20 AMP, RED COVER PLATE
- VOICE/DATA QUADJACK 2 VOICE/2 DATA RJ45-568 A/B
- COMMUNICATIONS JUNCTION BOXES
- LOAD CENTER
- SMOKE DETECTOR, 120V
- THERMOSTAT
- WALL MOUNTED FIRE EXTINGUISHER
- EXHAUST FAN
- WIRE MANAGEMENT BUSHING


**HUNTER**  
BUILDINGS & MANUFACTURING, LP

U.S. STANDARD  
LAYOUT #2  
BUILDING FLOOR PLAN

DRAWN:	BY AD	DATE 1/5/07	SCALE:	3/8"=1'-0"
CHECKED:	HGW	1/5/07	JOB. No.	STANDARD
ENGINEER:				
APPROVED:				

NO.	DATE	DESCRIPTION	BY	CHKD.	NO.	DATE	DESCRIPTION	BY	CHKD.
-	-	-	-	-	-	-	-	-	-
-	-	-	-	-	0	1/5/07	ISSUED FOR CONSTRUCTION	AD	HGW

LAYOUT #2 A-01 REV 0

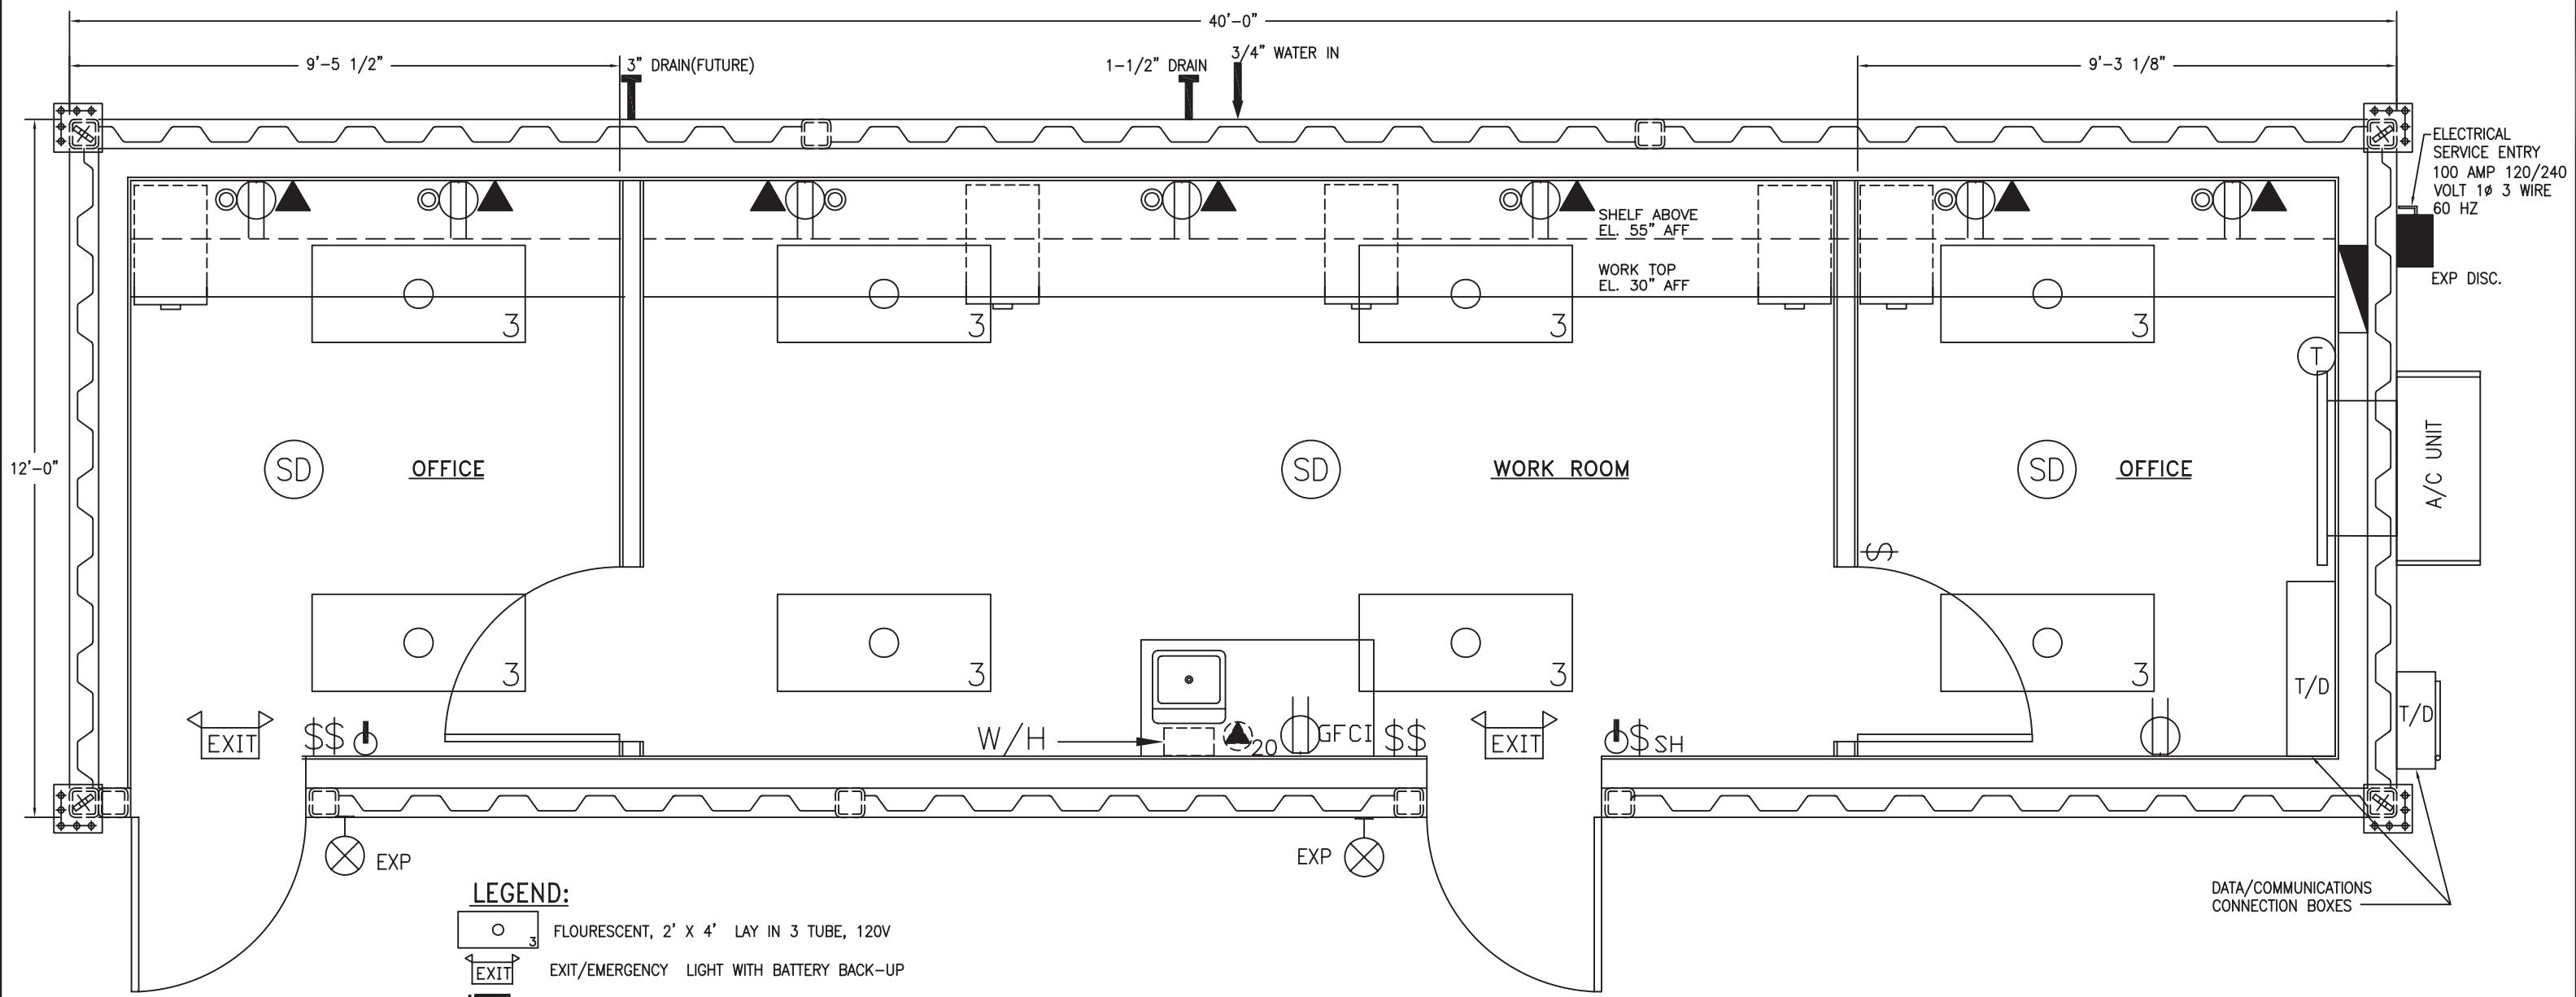

**LEGEND:**

- FLOURESCENT, 2' X 4' LAY IN 3 TUBE, 120V
- EXIT/EMERGENCY LIGHT WITH BATTERY BACK-UP
- EXTERIOR MAIN DISCONNECT, CLASS I DIV 2
- EXTERIOR LIGHT, 60W INCANDESCANT CLASS I DIV 2
- DUPLEX RECEPTACLE, 120V, 20 AMP
- DUPLEX RECEPTACLE GFCI 120V, 20 AMP
- WATER HEATER RECEPTACLE, 120V, 20 AMP TWIST'LOCK
- SWITCH SINGLE POLE, 120V 20 AMP
- SAFE HAVEN SWITCH SINGLE POLE, 120V 20 AMP, RED COVER PLATE
- VOICE/DATA QUADJACK 2 VOICE/2 DATA RJ45-568 A/B
- COMMUNICATIONS JUNCTION BOXES
- LOAD CENTER
- SMOKE DETECTOR, 120V
- THERMOSTAT
- WALL MOUNTED FIRE EXTINGUISHER
- EXHAUST FAN
- WIRE MANAGEMENT BUSHING


**HUNTER**  
BUILDINGS & MANUFACTURING, LP

U.S. STANDARD  
LAYOUT #4  
BUILDING FLOOR PLAN

DRAWN:	BY AD	DATE 1/05/07	SCALE:	3/8"=1'-0"
CHECKED:	HGW	1/05/07	JOB. No.	STANDARD
ENGINEER:				
APPROVED:				

NO.	DATE	DESCRIPTION	BY	CHKD.	NO.	DATE	DESCRIPTION	BY	CHKD.
-	-	-	-	-	-	-	-	-	-
-	-	-	-	-	0	1/05/07	ISSUED FOR CONSTRUCTION	AD	HGW

LAYOUT #4 A-01 REV 0

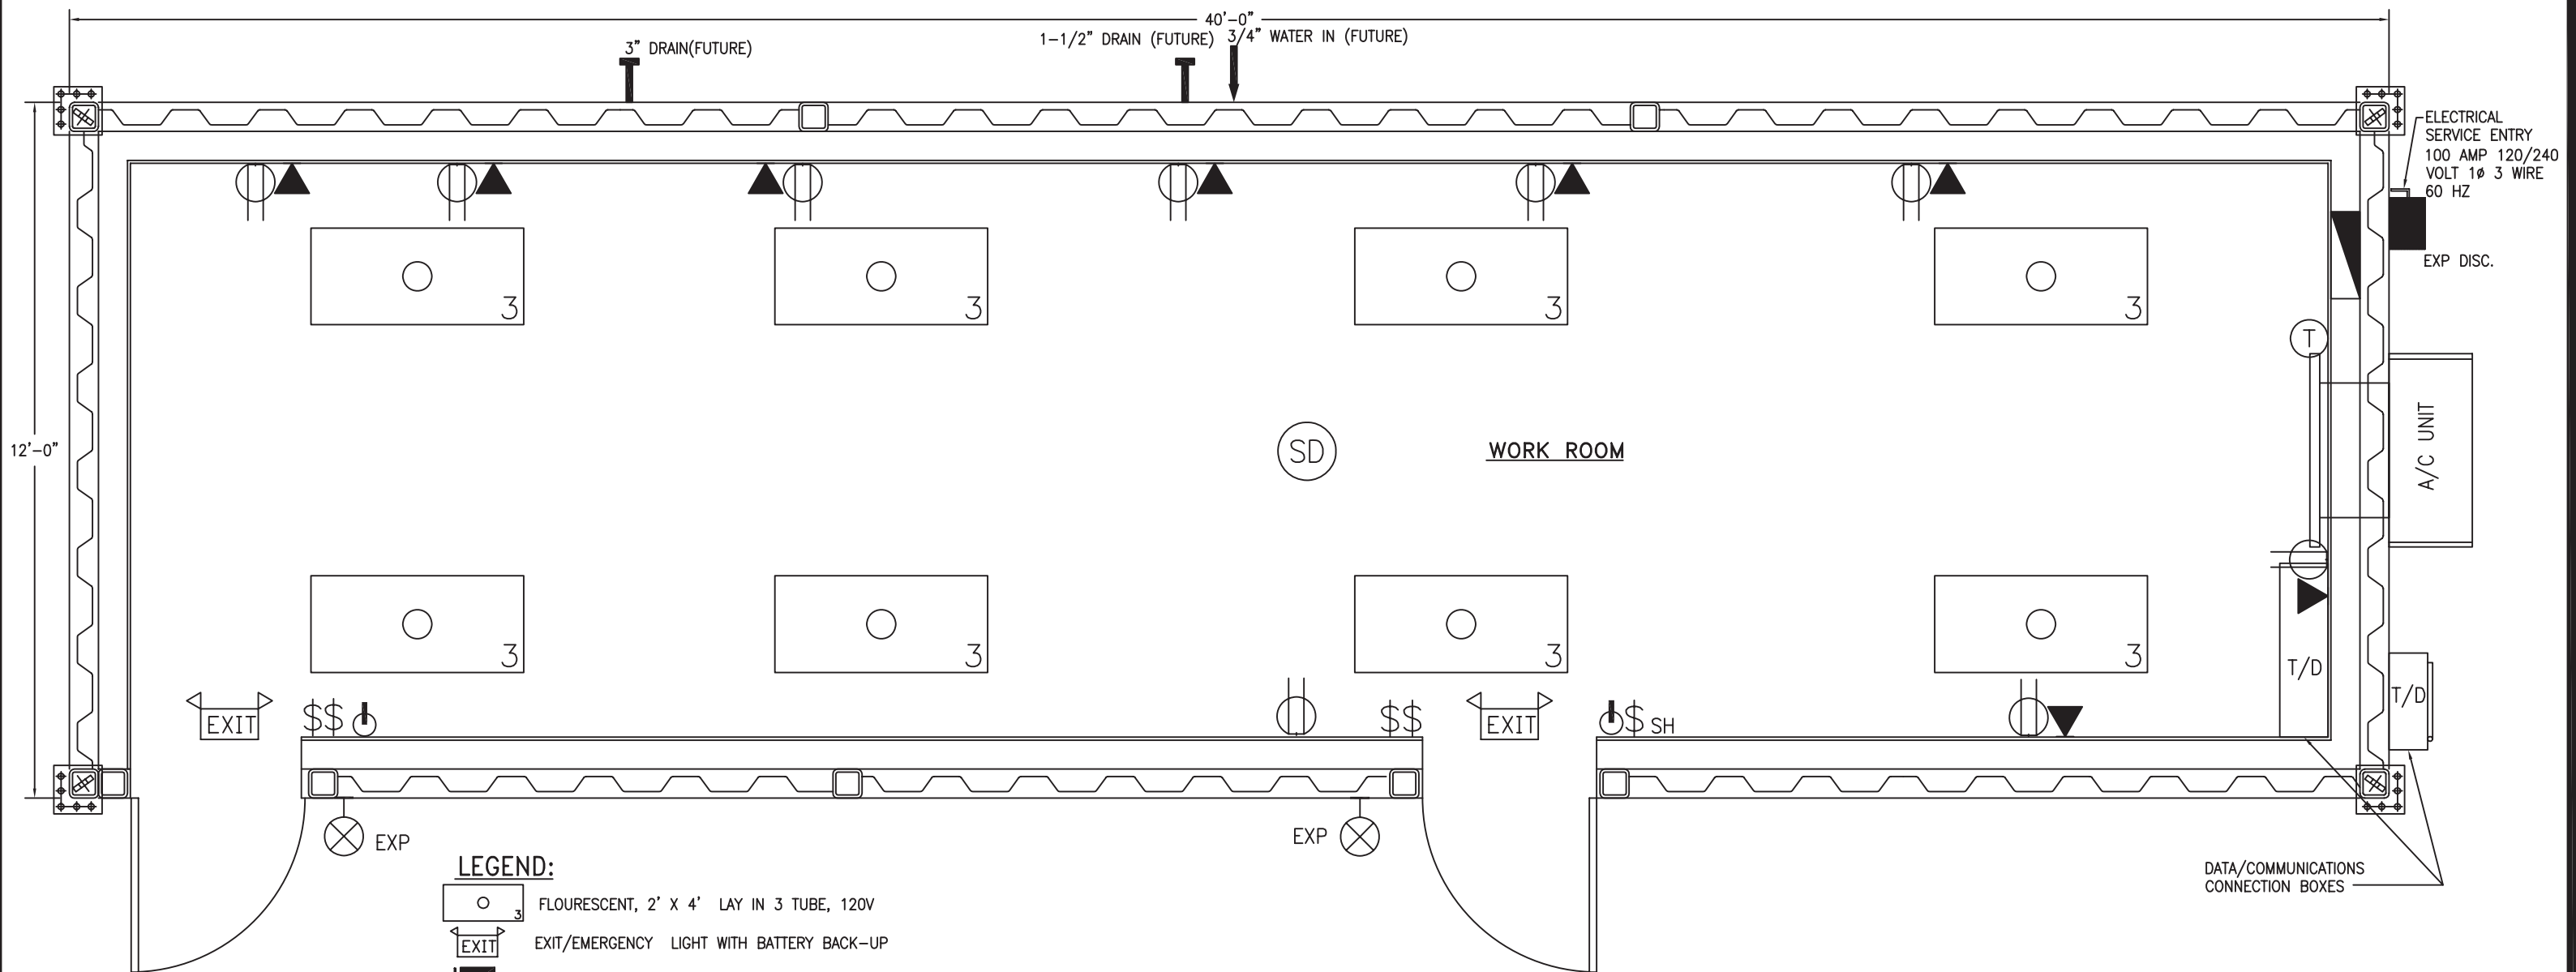

- LEGEND:**
- FLOURESCENT, 2' X 4' LAY IN 3 TUBE, 120V
  - EXIT/EMERGENCY LIGHT WITH BATTERY BACK-UP
  - EXTERIOR MAIN DISCONNECT, CLASS I DIV 2
  - EXTERIOR LIGHT, 60W INCANDESCANT CLASS I DIV 2
  - DUPLEX RECEPTACLE, 120V, 20 AMP
  - DUPLEX RECEPTACLE GFCI 120V, 20 AMP
  - WATER HEATER RECEPTACLE, 120V, 20 AMP TWIST'LOCK
  - SWITCH SINGLE POLE, 120V 20 AMP
  - SAFE HAVEN SWITCH SINGLE POLE, 120V 20 AMP, RED COVER PLATE
  - VOICE/DATA QUADJACK 2 VOICE/2 DATA RJ45-568 A/B
  - COMMUNICATIONS JUNCTION BOXES
  - LOAD CENTER
  - SMOKE DETECTOR, 120V
  - THERMOSTAT
  - WALL MOUNTED FIRE EXTINGUISHER
  - EXHAUST FAN
  - WIRE MANAGEMENT BUSHING

**HUNTER**  
BUILDINGS & MANUFACTURING, LP

U.S. STANDARD  
LAYOUT #5  
BUILDING FLOOR PLAN

DRAWN:	BY AD	DATE 1/05/07	SCALE:	3/8"=1'-0"
CHECKED:	HGW	1/05/07	JOB. No.	STANDARD
ENGINEER:				
APPROVED:				

LAYOUT #5 A-01

NO.	DATE	DESCRIPTION	BY	CHKD.	NO.	DATE	DESCRIPTION	BY	CHKD.
-	-	-	-	-	-	-	-	-	-
-	-	-	-	-	0	1/05/07	ISSUED FOR CONSTRUCTION	AD	HGW

REV
0