

LEGEND:

- FLOURESCENT, 2' X 4' LAY IN 3 TUBE, 120V
- EXIT/EMERGENCY LIGHT WITH BATTERY BACK-UP
- EXTERIOR MAIN DISCONNECT, CLASS I DIV 2
- EXTERIOR LIGHT, 60W INCANDESCANT CLASS I DIV 2
- DUPLEX RECEPTACLE, 120V, 20 AMP
- DUPLEX RECEPTACLE GFCI 120V, 20 AMP
- WATER HEATER RECEPTACLE, 120V, 20 AMP TWIST'LOCK
- SWITCH SINGLE POLE, 120V 20 AMP
- SAFE HAVEN SWITCH SINGLE POLE, 120V 20 AMP, RED COVER PLATE
- VOICE/DATA QUADJACK 2 VOICE/2 DATA RJ45-568 A/B
- COMMUNICATIONS JUNCTION BOXES
- LOAD CENTER
- SMOKE DETECTOR, 120V
- THERMOSTAT
- WALL MOUNTED FIRE EXTINGUISHER
- EXHAUST FAN
- WIRE MANAGEMENT BUSHING

HUNTER

BATON ROUGE LOUISIANA / HOUSTON TEXAS


U.S. STANDARD LAYOUT #1 BUILDING FLOOR PLAN

DRAWN:	BY	DATE	SCALE:	
	AD	1/5/07		3/8"=1'-0"
CHECKED:	HGW	1/5/07	JOB. No.	STANDARD
ENGINEER:				
APPROVED:				

NO.	DATE	DESCRIPTION	BY	CHKD.	NO.	DATE	DESCRIPTION	BY	CHKD.
-	-	-	-	-	-	-	-	-	-
-	-	-	-	-	0	1/5/07	ISSUED FOR CONSTRUCTION	AD	HGW

LAYOUT #1 A-01

REV
0

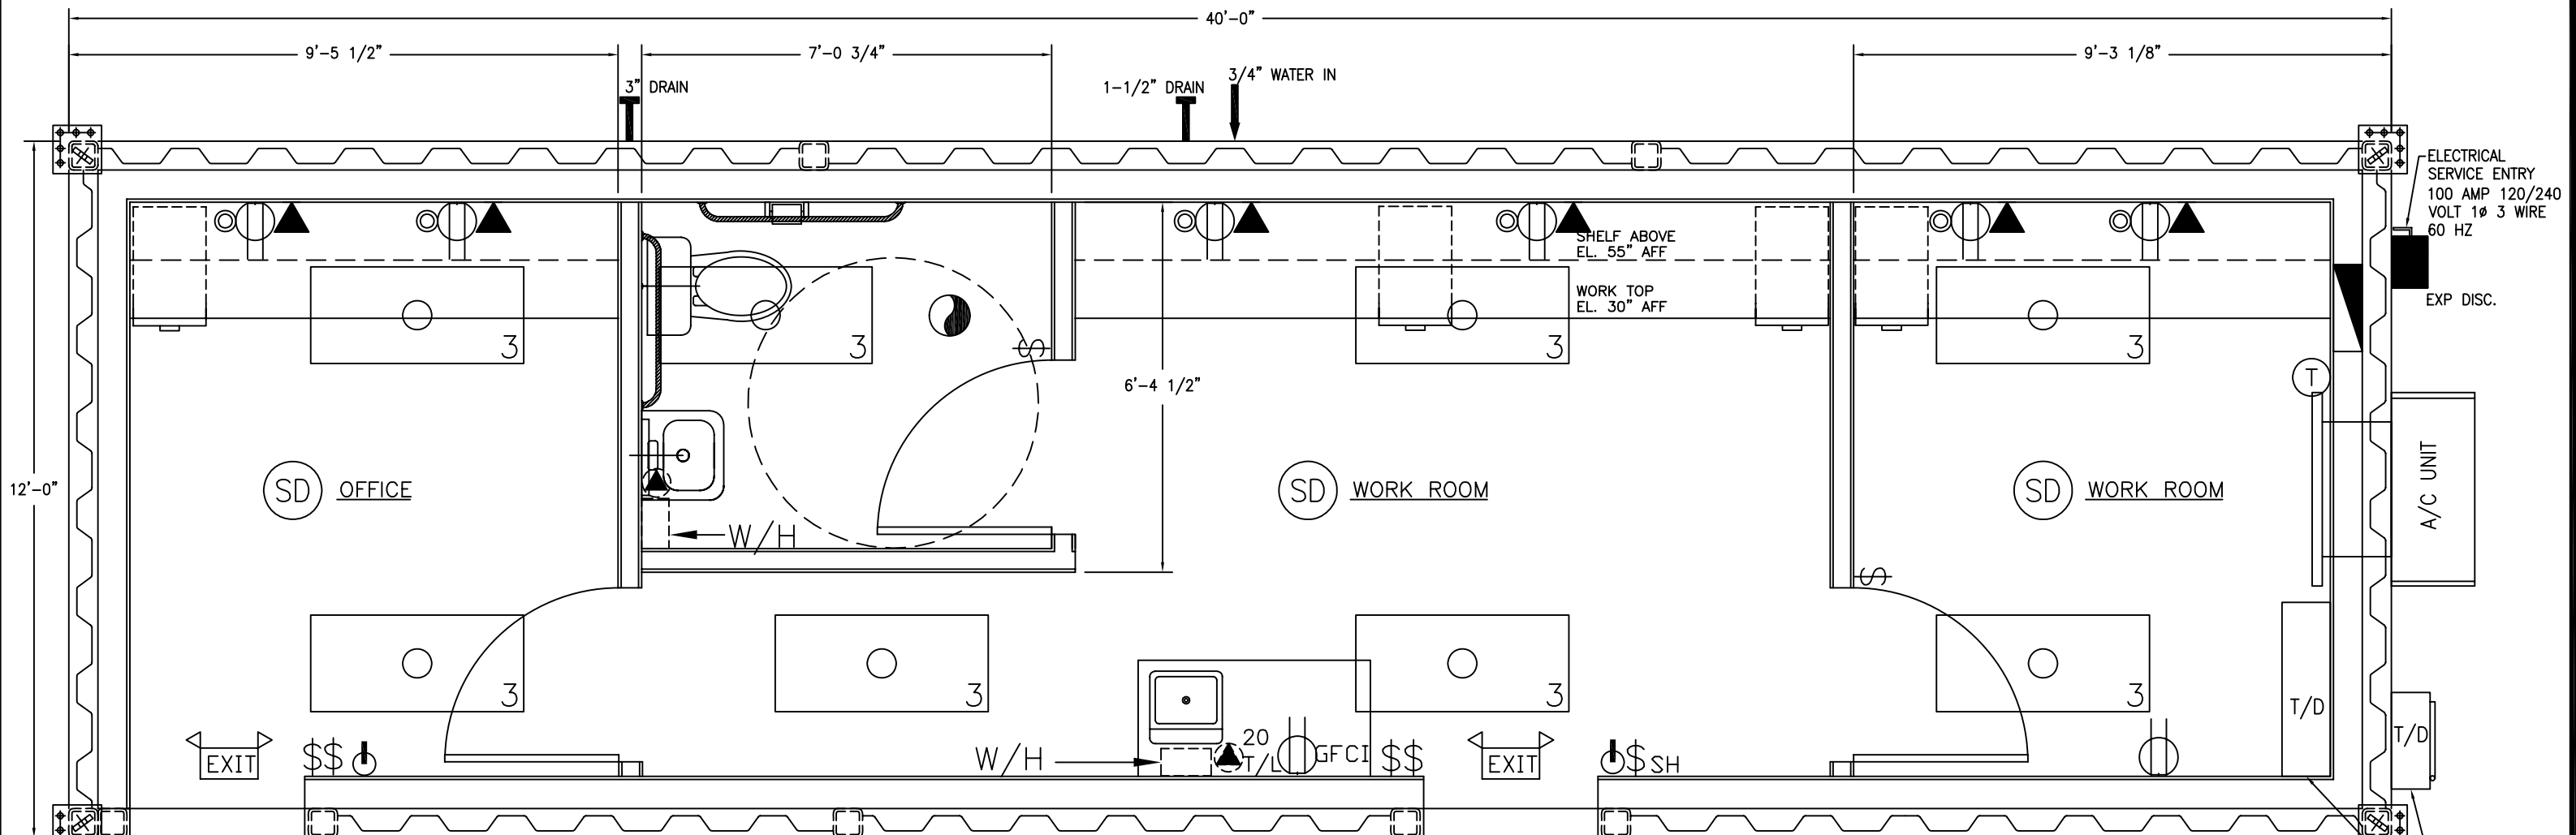

LEGEND:

- FLOURESCENT, 2' X 4' LAY IN 3 TUBE, 120V
- EXIT/EMERGENCY LIGHT WITH BATTERY BACK-UP
- EXTERIOR MAIN DISCONNECT, CLASS I DIV 2
- EXP EXTERIOR LIGHT, 60W INCANDESCANT CLASS I DIV 2
- DUPLEX RECEPTACLE, 120V, 20 AMP
- DUPLEX RECEPTACLE GFCI 120V, 20 AMP
- WATER HEATER RECEPTACLE, 120V, 20 AMP TWIST'LOCK
- SWITCH SINGLE POLE, 120V 20 AMP
- SAFE HAVEN SWITCH SINGLE POLE, 120V 20 AMP, RED COVER PLATE
- VOICE/DATA QUADJACK 2 VOICE/2 DATA RJ45-568 A/B
- T/D COMMUNICATIONS JUNCTION BOXES
- LOAD CENTER
- SMOKE DETECTOR, 120V
- T THERMOSTAT
- WALL MOUNTED FIRE EXTINGUISHER
- EXHAUST FAN
- WIRE MANAGEMENT BUSHING

HUNTER

BATON ROUGE LOUISIANA / HOUSTON TEXAS


**U.S. STANDARD
LAYOUT #2
BUILDING FLOOR PLAN**

DRAWN:	BY AD	DATE 1/5/07	SCALE:	3/8"=1'-0"
CHECKED:	HGW	1/5/07	JOB. No.	STANDARD
ENGINEER:				
APPROVED:				

LAYOUT #2 A-01

REV	0
-----	---

NO.	DATE	DESCRIPTION	BY	CHKD.	NO.	DATE	DESCRIPTION	BY	CHKD.
-	-	-	-	-	-	-	-	-	-
-	-	-	-	-	0	1/5/07	ISSUED FOR CONSTRUCTION	AD	HGW

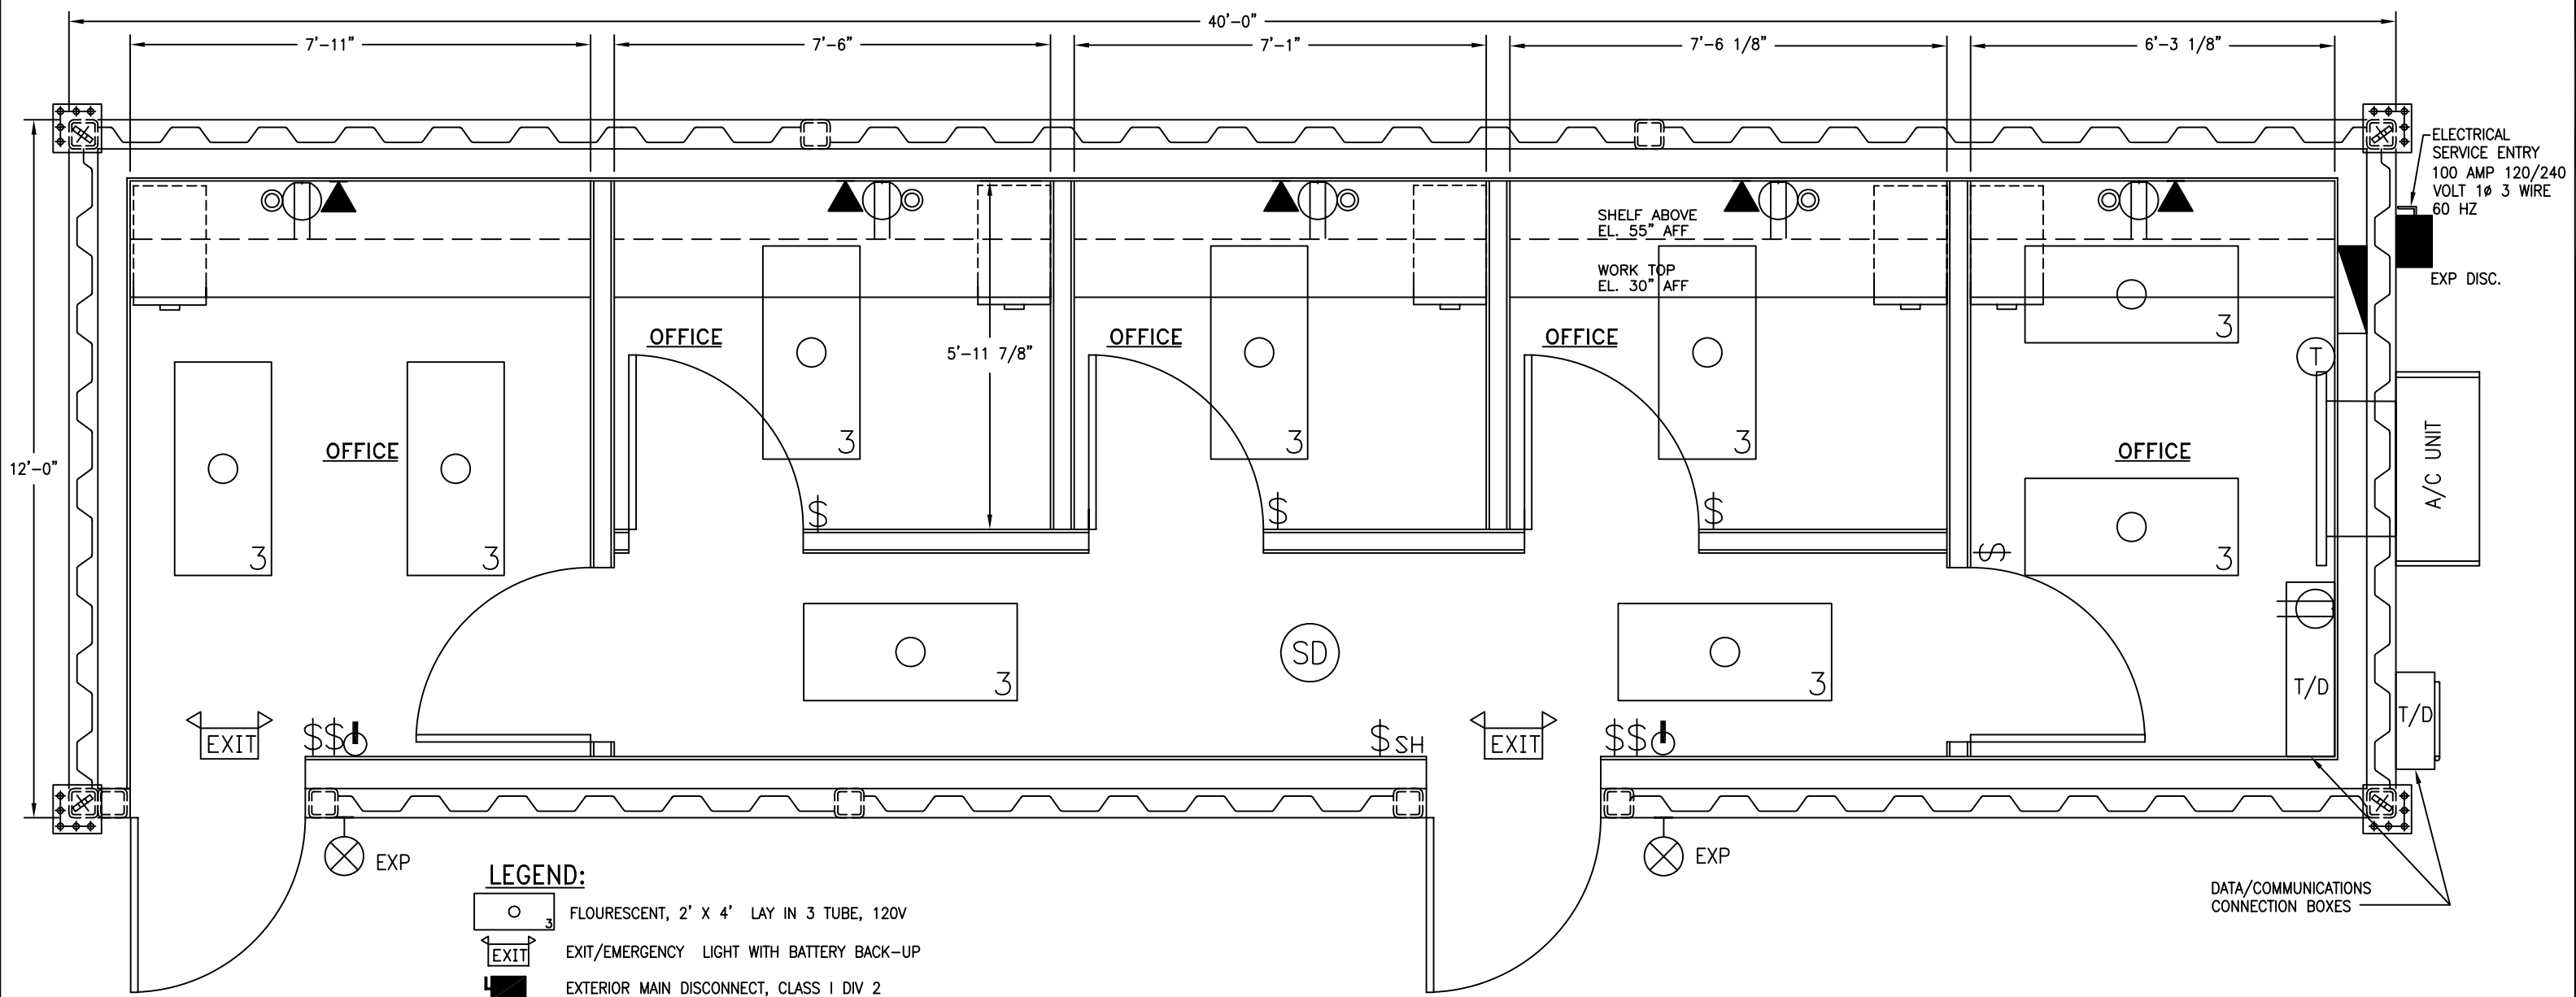

- LEGEND:**
- FLOURESCENT, 2' X 4' LAY IN 3 TUBE, 120V
 - EXIT/EMERGENCY LIGHT WITH BATTERY BACK-UP
 - EXTERIOR MAIN DISCONNECT, CLASS I DIV 2
 - EXTERIOR LIGHT, 60W INCANDESCANT CLASS I DIV 2
 - DUPLEX RECEPTACLE, 120V, 20 AMP
 - DUPLEX RECEPTACLE GFCI 120V, 20 AMP
 - WATER HEATER RECEPTACLE, 120V, 20 AMP TWIST'LOCK
 - SWITCH SINGLE POLE, 120V 20 AMP
 - SAFE HAVEN SWITCH SINGLE POLE, 120V 20 AMP, RED COVER PLATE
 - VOICE/DATA QUADJACK 2 VOICE/2 DATA RJ45-568 A/B
 - COMMUNICATIONS JUNCTION BOXES
 - LOAD CENTER
 - SMOKE DETECTOR, 120V
 - THERMOSTAT
 - WALL MOUNTED FIRE EXTINGUISHER
 - EXHAUST FAN
 - WIRE MANAGEMENT BUSHING


HUNTER
BATON ROUGE LOUISIANA / HOUSTON TEXAS

U.S. STANDARD
LAYOUT #3
BUILDING FLOOR PLAN

DRAWN:	BY AD	DATE 1/5/07	SCALE:	3/8"=1'-0"
CHECKED:	BY HGW	DATE 1/5/07	JOB. No.	STANDARD
ENGINEER:	_____			
APPROVED:	_____			

LAYOUT #3-A-01

NO.	DATE	DESCRIPTION	BY	CHKD.	NO.	DATE	DESCRIPTION	BY	CHKD.
-	-	-	-	-	-	-	-	-	-
-	-	-	-	-	0	1/5/07	ISSUED FOR CONSTRUCTION	AD	HGW

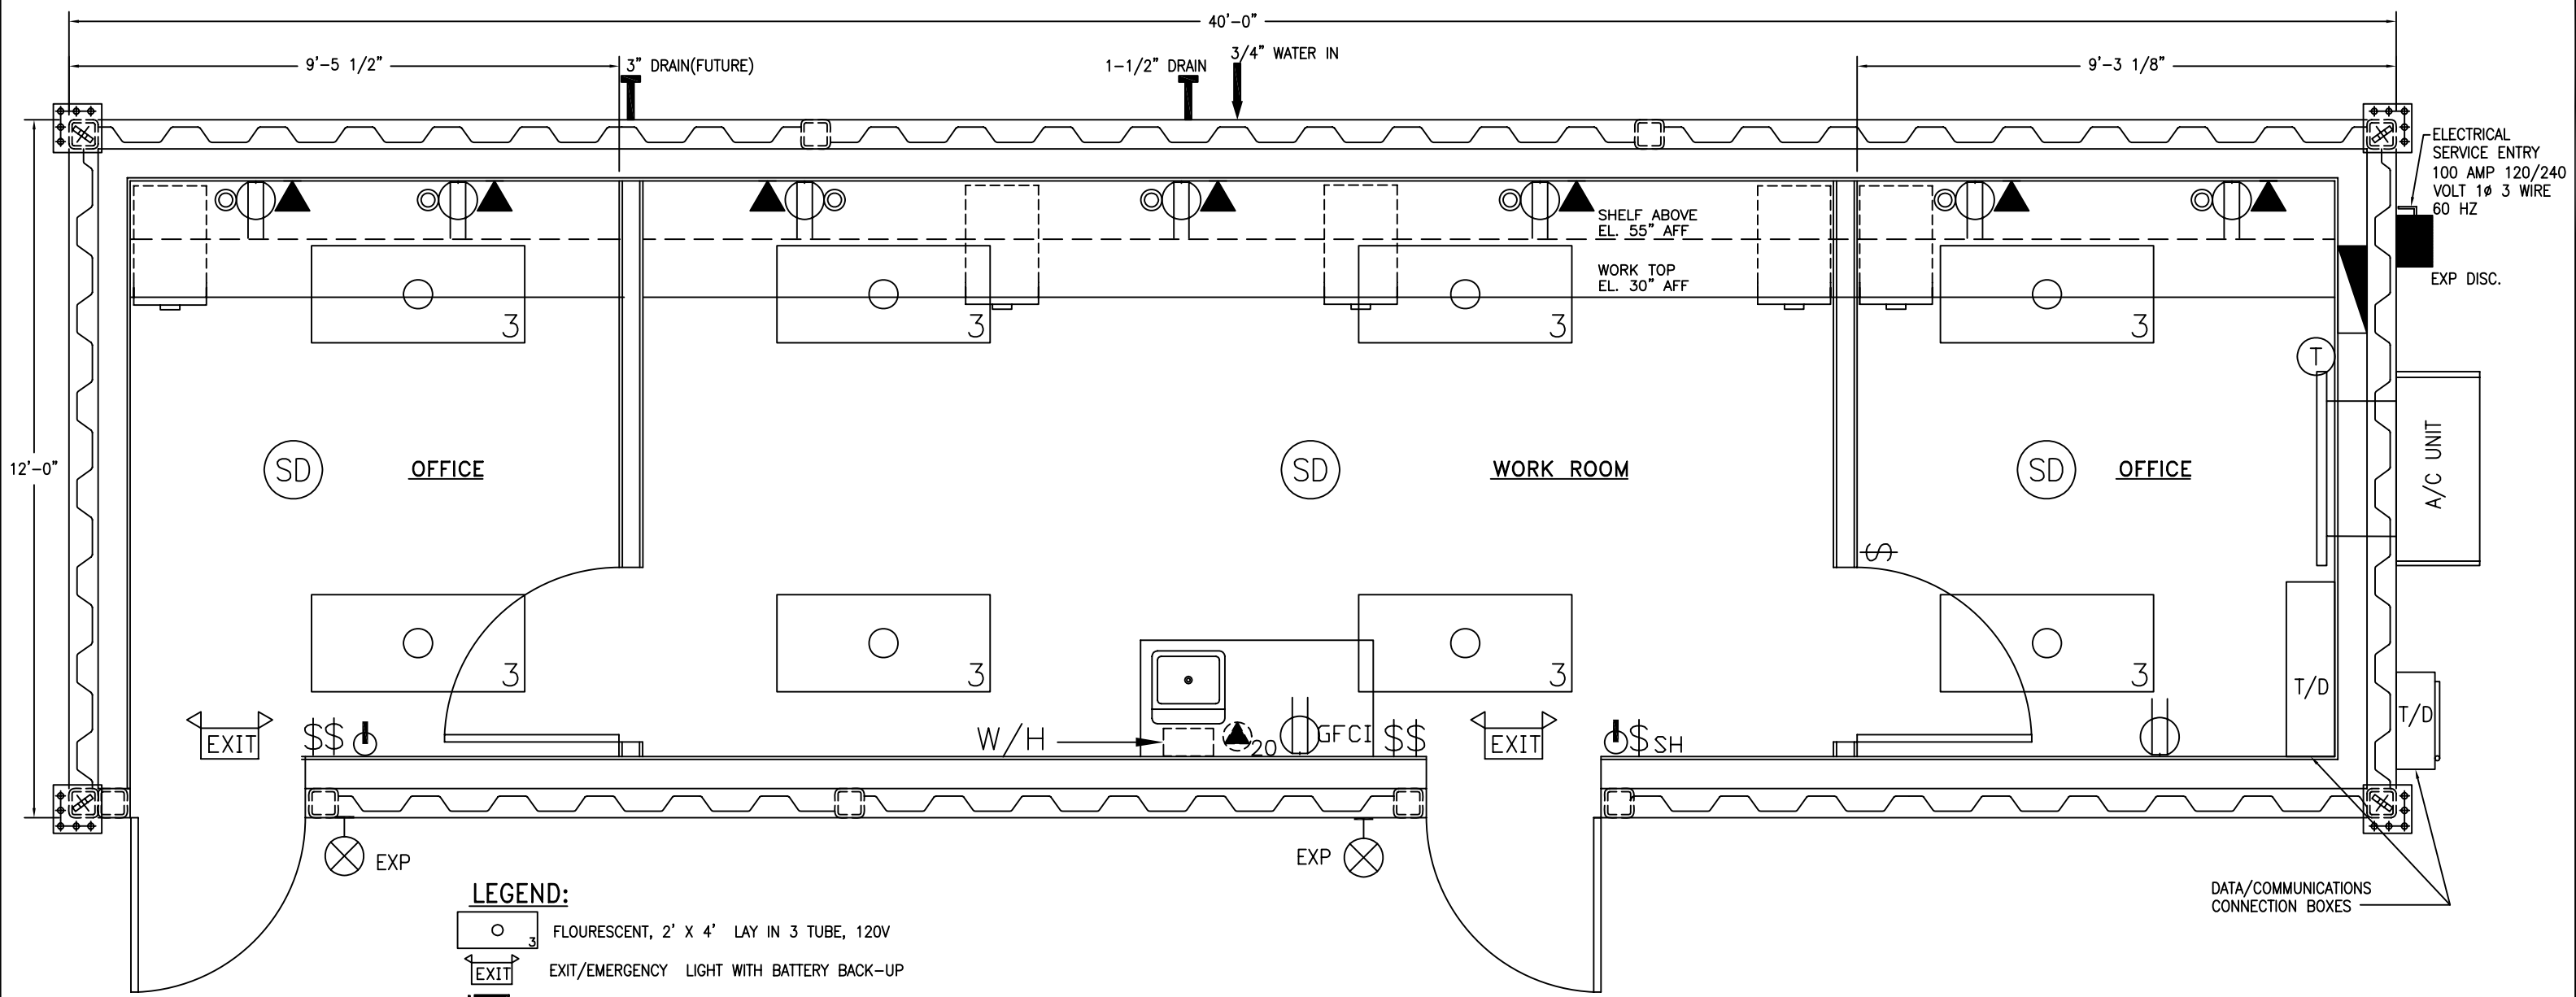

LEGEND:

- FLOURESCENT, 2' X 4' LAY IN 3 TUBE, 120V
- EXIT/EMERGENCY LIGHT WITH BATTERY BACK-UP
- EXTERIOR MAIN DISCONNECT, CLASS I DIV 2
- EXTERIOR LIGHT, 60W INCANDESCANT CLASS I DIV 2
- DUPLEX RECEPTACLE, 120V, 20 AMP
- DUPLEX RECEPTACLE GFCI 120V, 20 AMP
- WATER HEATER RECEPTACLE, 120V, 20 AMP TWIST'LOCK
- SWITCH SINGLE POLE, 120V 20 AMP
- SAFE HAVEN SWITCH SINGLE POLE, 120V 20 AMP, RED COVER PLATE
- VOICE/DATA QUADJACK 2 VOICE/2 DATA RJ45-568 A/B
- COMMUNICATIONS JUNCTION BOXES
- LOAD CENTER
- SMOKE DETECTOR, 120V
- THERMOSTAT
- WALL MOUNTED FIRE EXTINGUISHER
- EXHAUST FAN
- WIRE MANAGEMENT BUSHING

HUNTER

BATON ROUGE LOUISIANA / HOUSTON TEXAS


**U.S. STANDARD
LAYOUT #4
BUILDING FLOOR PLAN**

DRAWN:	BY AD	DATE 1/05/07	SCALE:	3/8"=1'-0"
CHECKED:	BY HGW	DATE 1/05/07	JOB. No.	STANDARD
ENGINEER:				
APPROVED:				

LAYOUT #4 A-01

REV	0
-----	---

NO.	DATE	DESCRIPTION	BY	CHKD.	NO.	DATE	DESCRIPTION	BY	CHKD.
-	-	-	-	-	-	-	-	-	-
-	-	-	-	-	0	1/05/07	ISSUED FOR CONSTRUCTION	AD	HGW

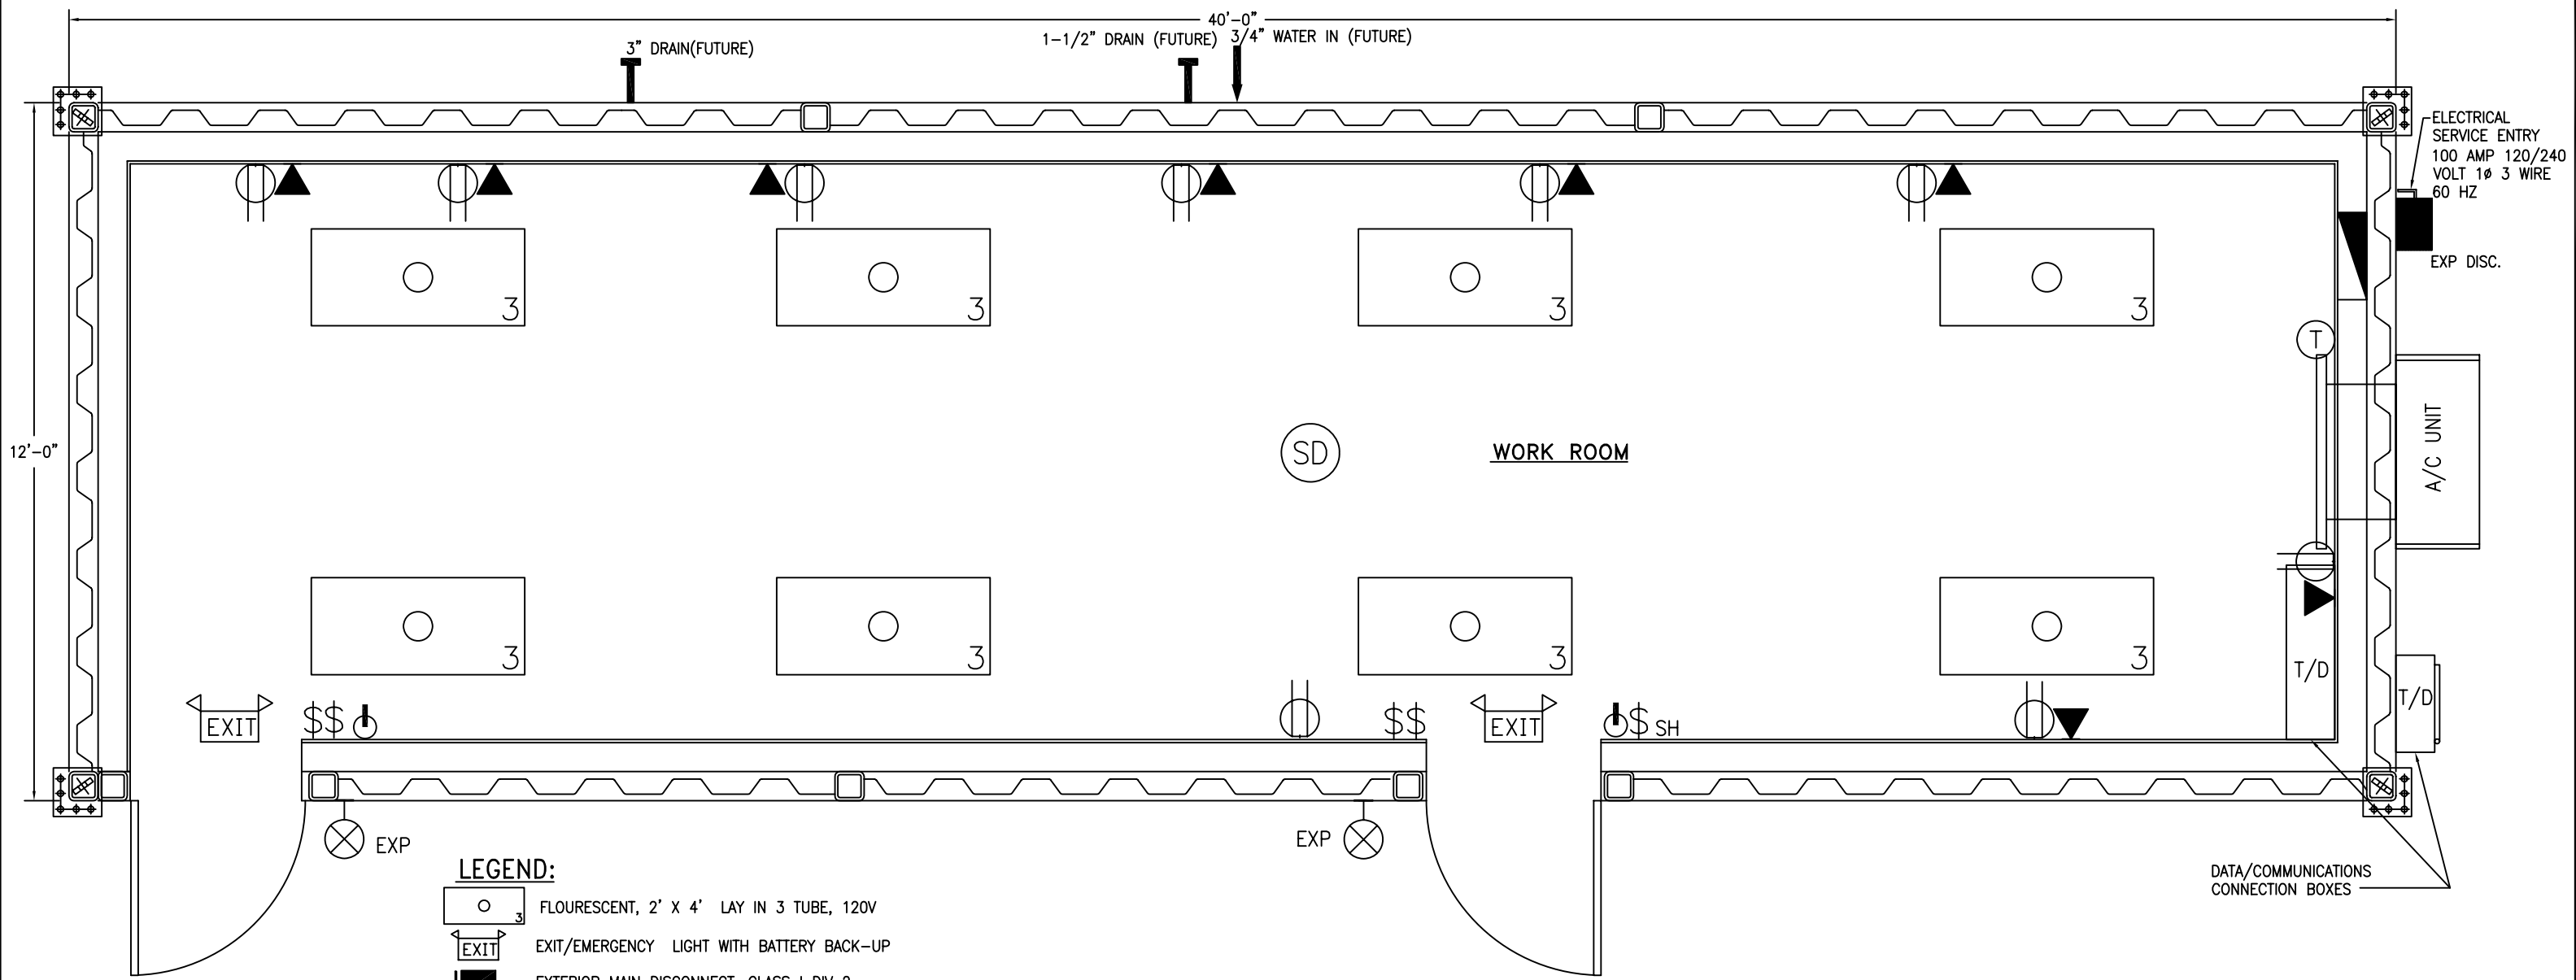

- LEGEND:**
- FLOURESCENT, 2' X 4' LAY IN 3 TUBE, 120V
 - EXIT/EMERGENCY LIGHT WITH BATTERY BACK-UP
 - EXTERIOR MAIN DISCONNECT, CLASS I DIV 2
 - EXTERIOR LIGHT, 60W INCANDESCANT CLASS I DIV 2
 - DUPLEX RECEPTACLE, 120V, 20 AMP
 - DUPLEX RECEPTACLE GFCI 120V, 20 AMP
 - WATER HEATER RECEPTACLE, 120V, 20 AMP TWIST'LOCK
 - SWITCH SINGLE POLE, 120V 20 AMP
 - SAFE HAVEN SWITCH SINGLE POLE, 120V 20 AMP, RED COVER PLATE
 - VOICE/DATA QUADJACK 2 VOICE/2 DATA RJ45-568 A/B
 - COMMUNICATIONS JUNCTION BOXES
 - LOAD CENTER
 - SMOKE DETECTOR, 120V
 - THERMOSTAT
 - WALL MOUNTED FIRE EXTINGUISHER
 - EXHAUST FAN
 - WIRE MANAGEMENT BUSHING

HUNTER

BATON ROUGE LOUISIANA / HOUSTON TEXAS

U.S. STANDARD
LAYOUT #5
BUILDING FLOOR PLAN

DRAWN:	BY AD	DATE 1/05/07	SCALE:	3/8"=1'-0"
CHECKED:	HGW	1/05/07	JOB. No.	STANDARD
ENGINEER:				
APPROVED:				

LAYOUT #5 A-01

NO.	DATE	DESCRIPTION	BY	CHKD.	NO.	DATE	DESCRIPTION	BY	CHKD.
-	-	-	-	-	-	-	-	-	-
-	-	-	-	-	0	1/05/07	ISSUED FOR CONSTRUCTION	AD	HGW

REV	0
-----	---